


SAFETECH

April 6, 2019

Marriott Griffin Gate_Grand Ballroom C-E Lexington, KY

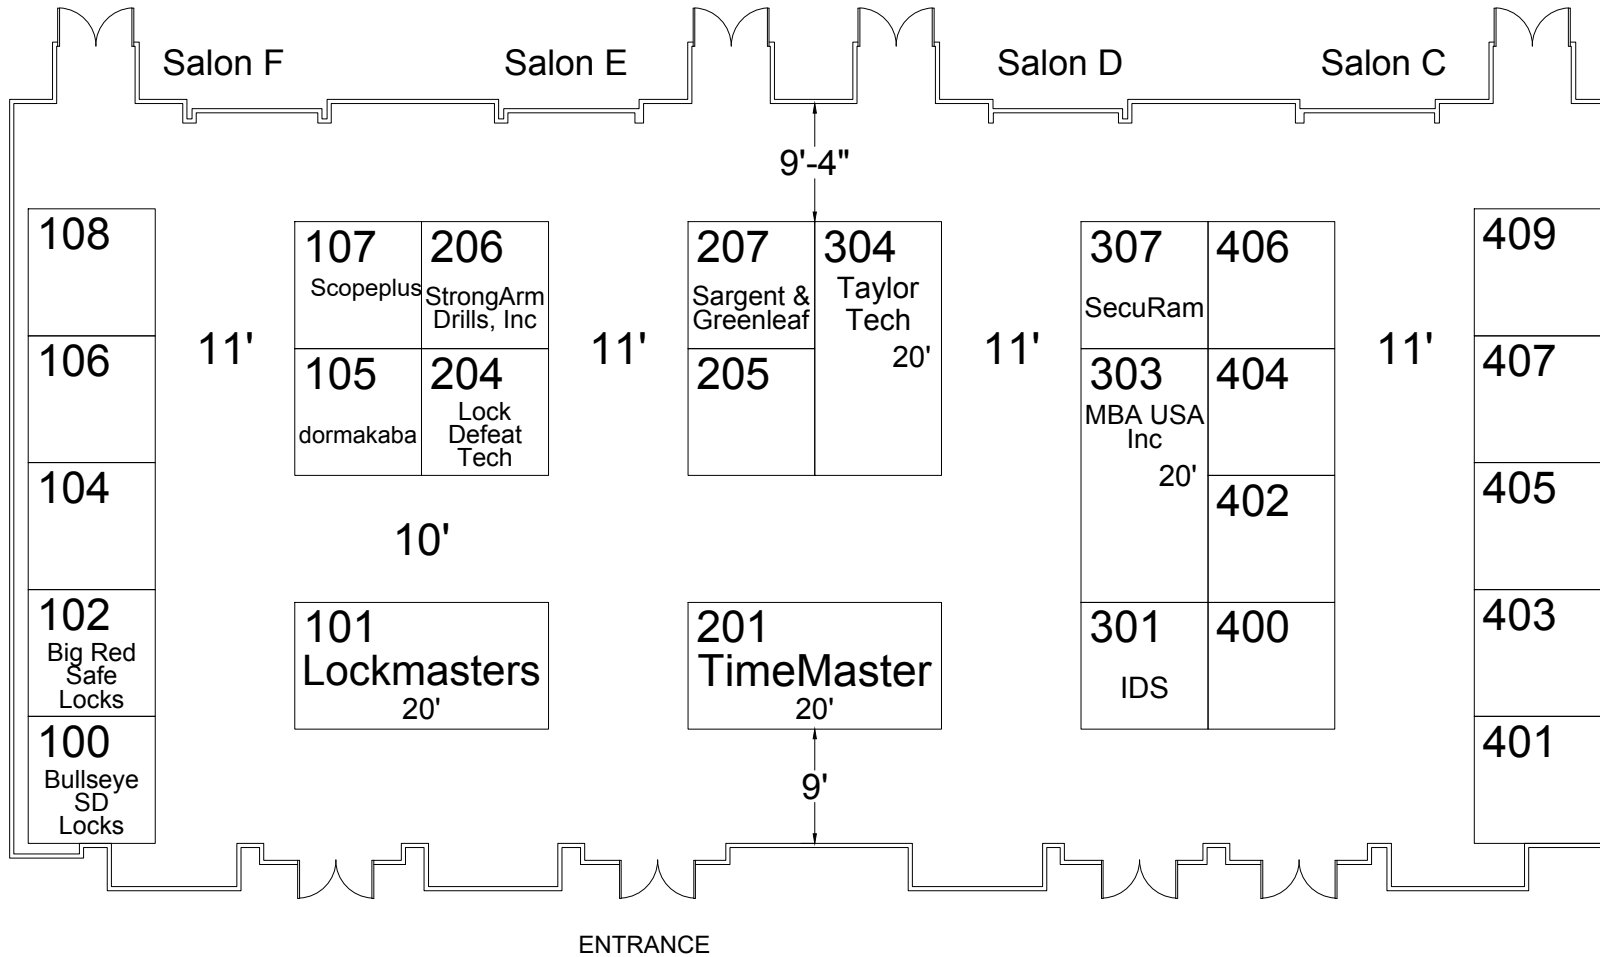

Show Information	
Show Name	SAFETECH
Show Dates	04/06/19
Move-In	03/31/19
Job #	1197210419
AE	Fred Barkley

Inventory as of 10/09/2018			
Dimension	Size	Qty	SqFt
10'x10'	100	22	2,200
10'x20'	200	4	800
Totals:		26	3,000

Floor Plan Legend	
FE	Fire Extinguisher
FS	Fire Strobe
FHC	Fire Hose Cabinet

Venue Info	
Building Name	Marriott Griffin Gate
Hall	Grand Ballroom C-E
Floor	Floor
Address	1800 Newtown Pike, Lexington KY 40511

Drawing Information	
File Path	J:\SES Floorplans\01_SES_SHOW FLOORPLANS\2019\04_April
File Name	04_SAFETECH_1197210419.dwg
Drawn By	JIP
Last Saved	10/2/2018 3:24 PM
Saved By	jperez
Tab	Floorplan
Paper Size	ANSI full bleed A (11.00 x 8.50 Inches)
Scale	? = 1'-0"

1531 Carroll Drive NW
Atlanta, GA 30318
(v) 404-720-8600
(f) 404-720-8750

Shepard Exposition Services has made every effort to ensure the accuracy of all information contained on this floor plan. However, no warranties, either expressed or implied, are made with respect to this floor plan. If the location of building columns, utilities or other architectural components of the facility is a sole responsibility of the exhibitor/show management to physically inspect the facility to verify all dimensions and locations.

SUBJECT TO FIRE MARSHAL APPROVAL