


SAFETECH

April 27, 2024

Hyatt Regency Tulsa - Tulsa Ballroom South/Central - Concourse Level Tulsa, OK

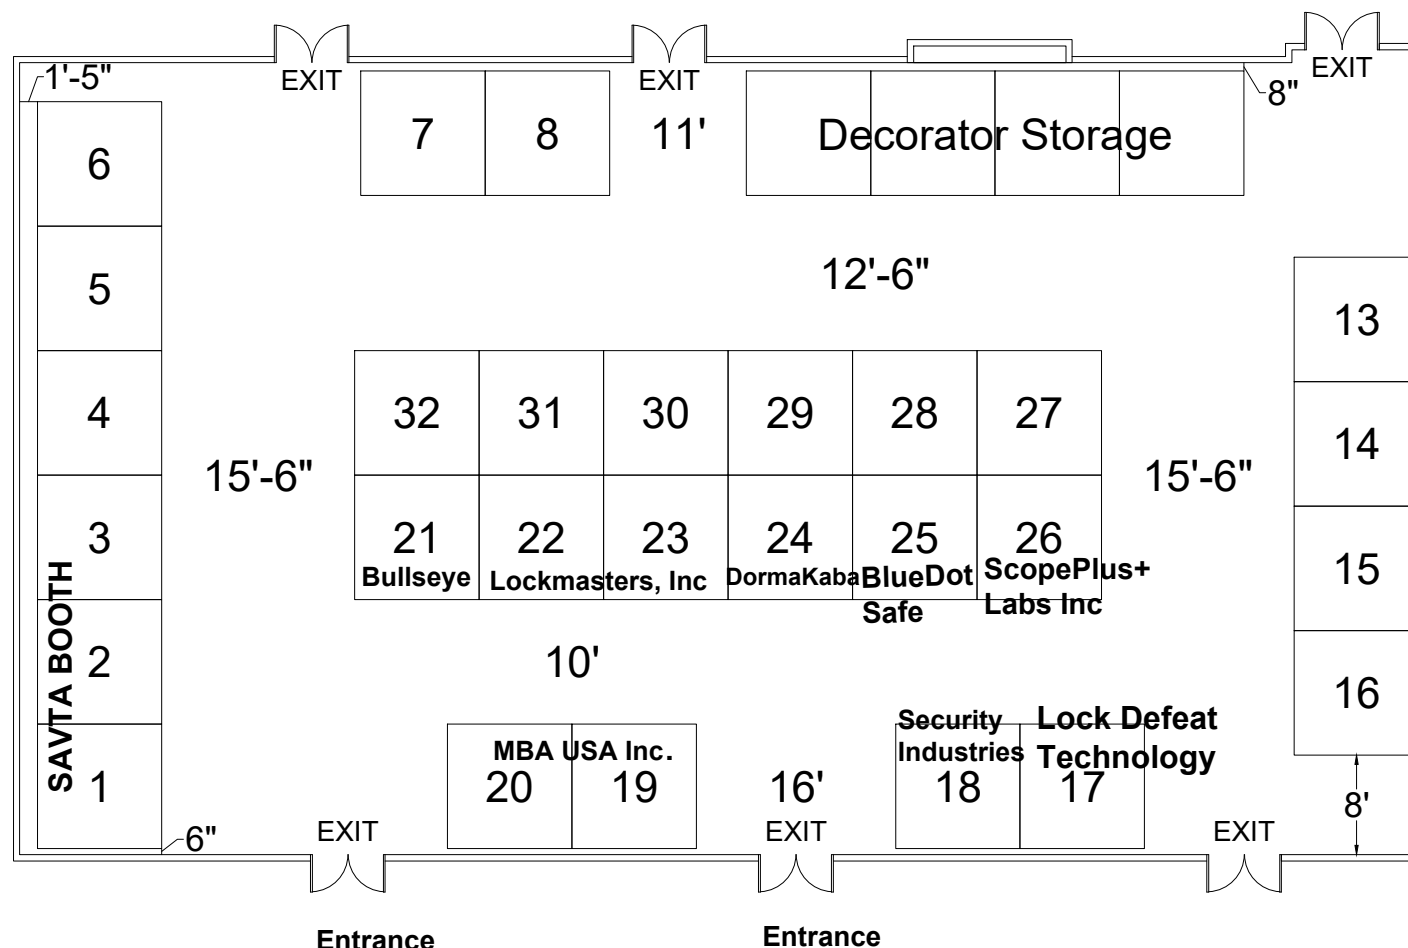

| Show Information | |
|------------------|-----------------|
| Show Name | SAFETECH |
| Show Dates | April 27, 2024 |
| Move-In | April 21, 2024 |
| Job # | T194280424 |
| AE | Andrea Goldberg |

Inventory as of 04/19/2023

| Dimension | Size | Qty | SqFt |
|-----------|------|-----|-------|
| 10'x10' | 100 | 32 | 3,200 |
| Totals: | | 32 | 3,200 |

| Floor Plan Legend | |
|-------------------|-------------------|
| FE | Fire Extinguisher |
| FS | Fire Strobe |
| FHC | Fire Hose Cabinet |
| | |
| | |
| | |

| Venue Info | |
|---------------|---------------------------------|
| Building Name | Hyatt Regency Tulsa |
| Hall | Tulsa Ballroom South/Central |
| Floor | Concourse Level |
| Address | 100 E 2nd St Tulsa, OK 74103 |

| Drawing Information | |
|---------------------|---|
| File Path | J:\01_Floor Plans_01_SEE SHOW_FLOORPLANS\2024\SAFETECH_T194280424.dwg |
| File Name | SAFETECH_T194280424.dwg |
| Drawn By | Jayson de Nieva |
| Last Saved | 4/13/2023 11:52 AM |
| Saved By | Jdenieva |
| Tab | Floorplan |
| Paper Size | ANSI full bleed A (11.00 x 8.50 Inches) |
| Scale | NTS |

1531 Carroll Drive NW
Atlanta, GA 30318
(v) 404-720-8600
(f) 404-720-8750