


SAFETECH

April 27, 2024

Hyatt Regency Tulsa - Tulsa Ballroom South/Central - Concourse Level Tulsa, OK

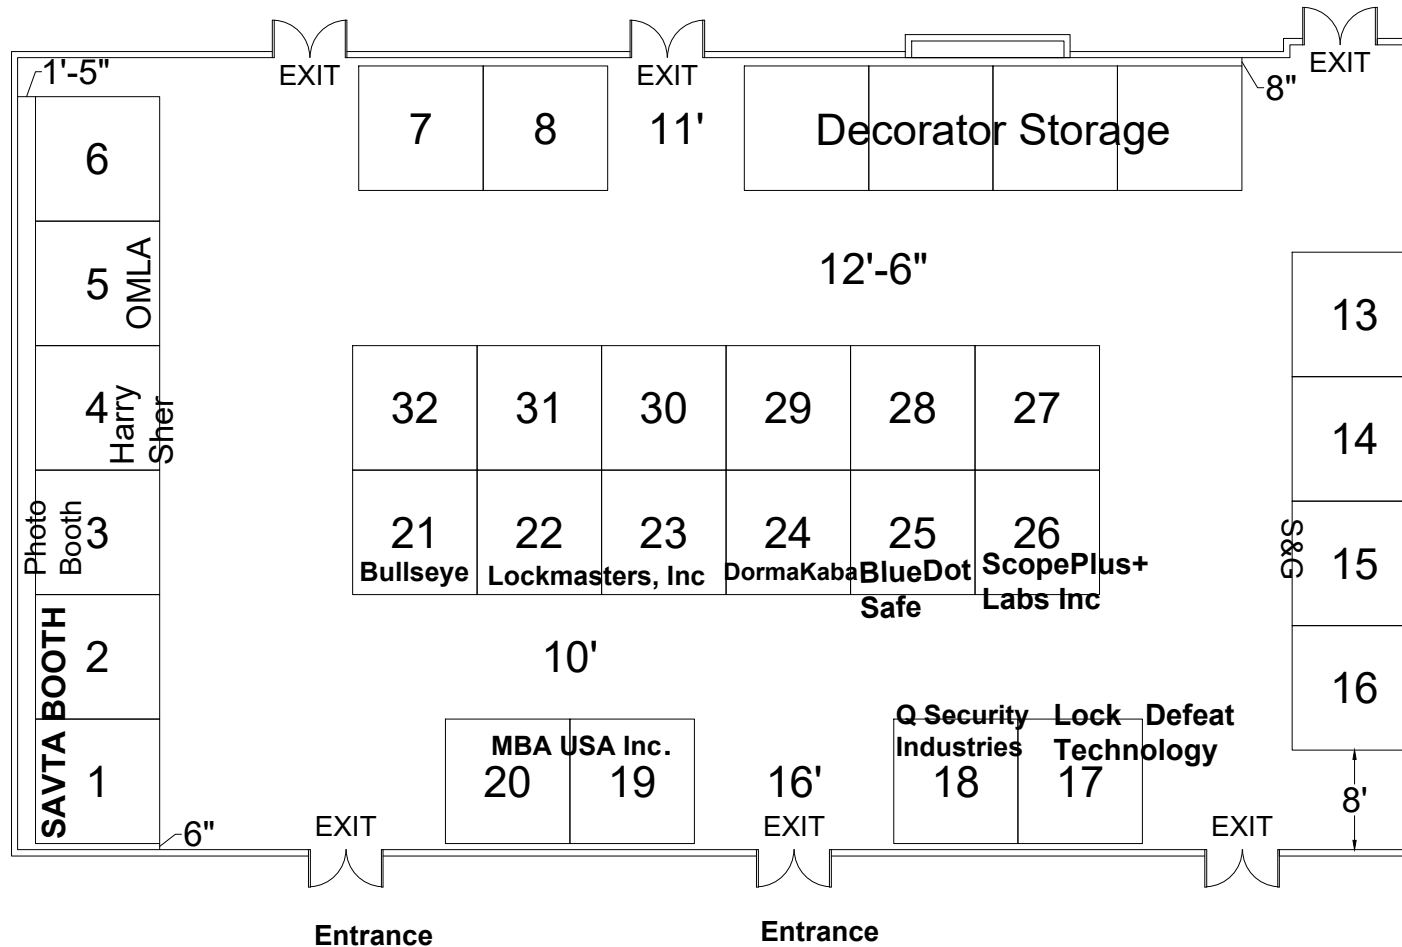

Show Information	
Show Name	SAFETECH
Show Dates	April 27, 2024
Move-In	April 21, 2024
Job #	T194280424
AE	Andrea Goldberg

Inventory as of 04/19/2023

Dimension	Size	Qty	SqFt
10'x10'	100	32	3,200
Totals:		32	3,200

Floor Plan Legend	
FE	Fire Extinguisher
FS	Fire Strobe
FHC	Fire Hose Cabinet

Venue Info	
Building Name	Hyatt Regency Tulsa
Hall	Tulsa Ballroom South/Central
Floor	Concourse Level
Address	100 E 2nd St Tulsa, OK 74103

Drawing Information	
File Path	Z:\01_Floor Plans_01_SEE SHOW FLOORPLANS\2024\SAFETECH\T194280424.dwg
File Name	SAFETECH_T194280424.dwg
Drawn By	Jayson de Nieva
Last Saved	4/13/2023 11:52 AM
Saved By	Jdenieva
Tab	Floorplan
Paper Size	ANSI full bleed A (11.00 x 8.50 Inches)
Scale	NTS