



SAFETECH

April 12, 2025

Lexington Griffin Gate Marriott Golf Resort & Spa - Grand Ballroom C-F Lexington, KY

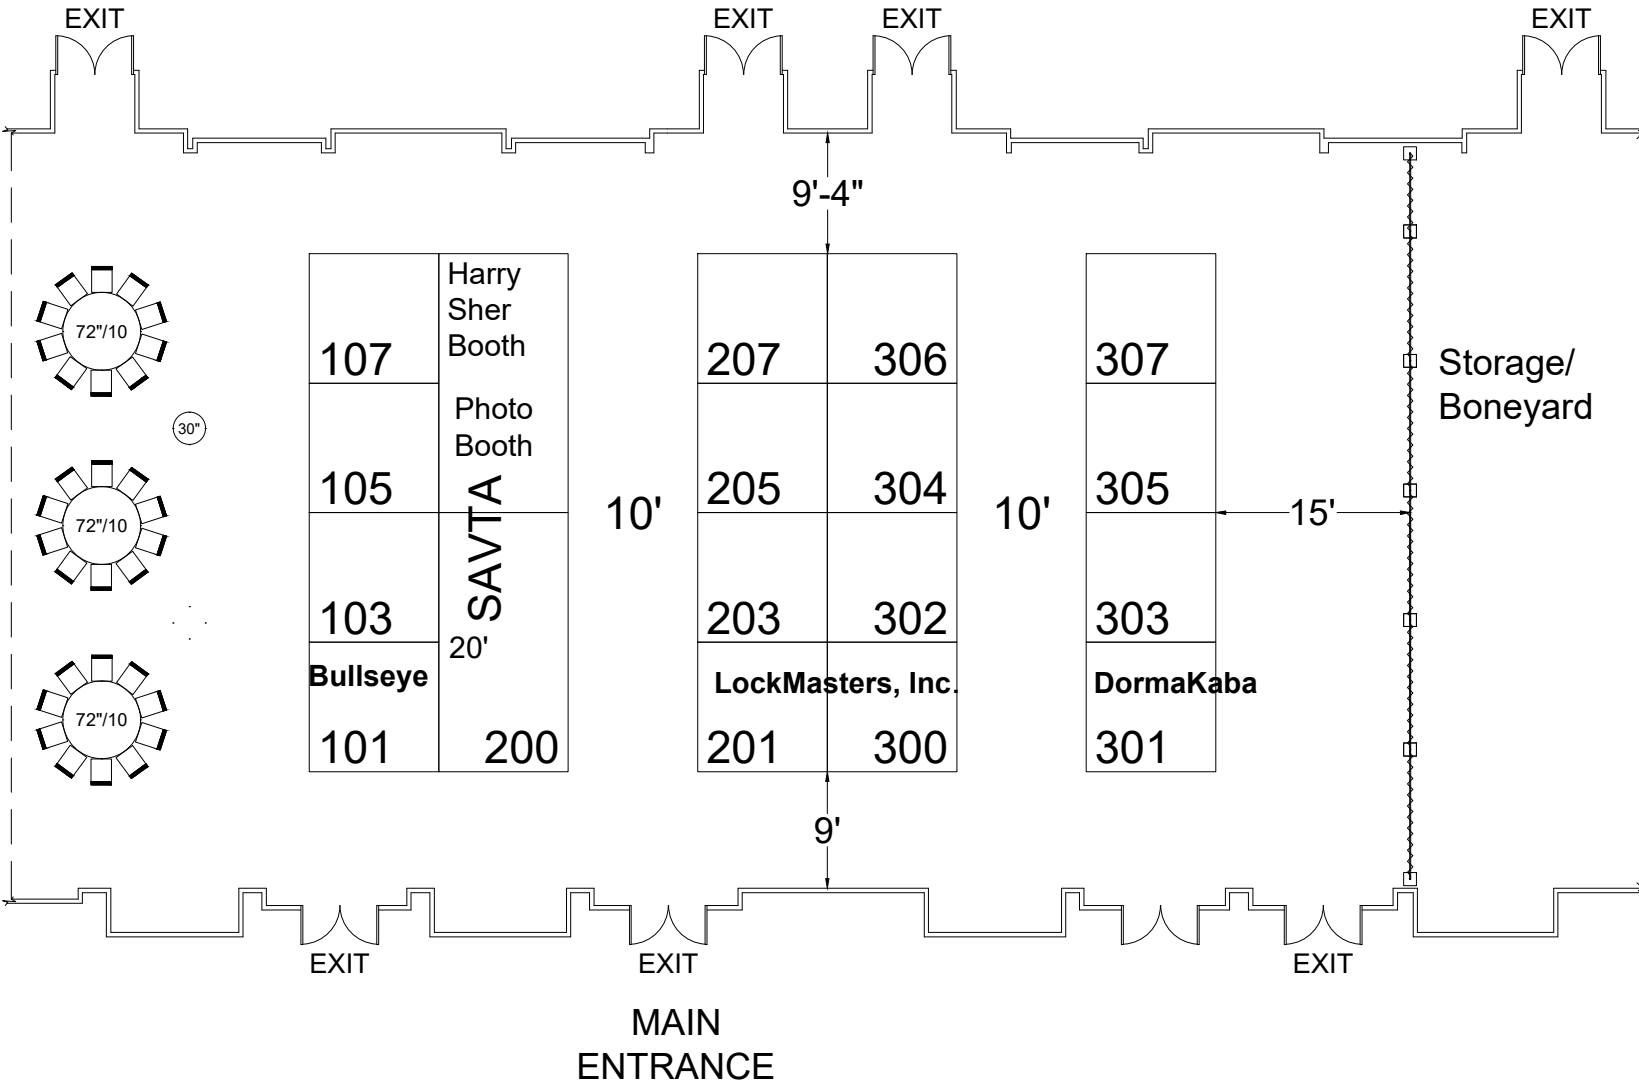

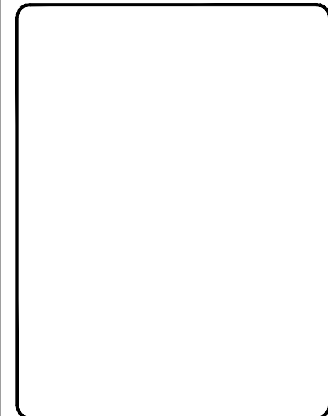

FS	Fire Strobe
FHC	Fire Hose Cabinet

Venue Info	
Building Name	Lexington Griffin Gate Marriott Golf Resort & Spa
Hall	Grand Ballroom C-F
Floor	
Address	1800 Newtown Pike Lexington, KY 40511

Drawing Information	
File Path	J:\01_Floor Plans_01_SEE SHOW F2019422
File Name	SAFETECH_G192910422.dwg
Drawn By	Theresa Cannatella
Last Saved	3/11/2022 4:47 PM
Saved By	Jperez
Tab	Floorplan
Paper Size	ANSI full bleed A (11.00 x 8.50 Inches)
Scale	NTS